

Date: July 28, 2016

Project: Kake Bulk Fuel and Rural Power
System Upgrades

Solicitation No.: 16155

Addendum No. Six

TO ALL PLANHOLDERS:

The enclosed addendum amends the proposal documents for the above referenced Project.

Acknowledgment of this addendum is required on the Proposal Submittal. Failure to do so may subject the proposer to disqualification.

Sincerely,

Rich Wooten, CDT, CPSM
Contracting Officer

ADDENDUM TO CONTRACT DOCUMENTS	Page Number 1	No. of Pages One Page (2 page drawing)
Addendum No. SIX	Date Addendum Issued: July 28, 2016	
Issuing Office Rich Wooten, CDT, CPSM Alaska Industrial Development Export Authority 813 W Northern Lights Blvd Anchorage, AK 99503 Phone: (907) 771-3019 Fax: (907) 771-3044	Previous Addenda Issued Addendum One, July 5, 2016 Addendum Two, July 11, 2016 Addendum Three, July 15, 2016 Addendum Four, July 20, 2016 Addendum Five July 27, 2016	
Project: Kake Bulk Fuel and Rural Power System Upgrades Solicitation No.: 16155	Date and Hour Quotes Due: August 2, 2016 at 3:00 p.m., prevailing Anchorage time.	

NOTICE TO PROPOSERS:

Proposers must acknowledge receipt of this addendum prior to the hour and date set for proposal due date by one of the following methods:

- (a) By acknowledging receipt of this addendum on the proposal form submitted.
- (b) By email or telefacsimile which includes a reference to the project and addendum number.

The proposal documents require acknowledgment individually of all addenda to the drawings and/or specifications. This is a mandatory requirement and any proposal received without acknowledgment of receipt of addenda may be classified as not being a responsive proposal. If, by virtue of this addendum it is desired to modify a proposal already submitted, such modification may be made by email or telefacsimile provided such an email or telefacsimile makes reference to this addendum and is received prior to the opening hour and date specified above.

The Proposal documents for the above project are amended as follows (All other terms and conditions remain unchanged):

PROPOSAL AND CONTRACT REQUIREMENTS

BIDDING AND CONTRACT DOCUMENTS

The proposal due date has been changed from July 28, 2016 to August 2, 2016 at 3:00p.m

DESIGN DRAWINGS


A. Modifications to Kake Rural Power Systems Upgrade Schedule B DRAWINGS:

1. Sheet E2.01, General Note 1:

Delete the entire sheet and replace with the attached Sheet E2.01 which includes the following changes:

- *Scale on 2.01 is incorrect, should be 1"=30'.*
- *(1ea) 2" crossing from CP-A to CP-B. Tag #1 on E5.01 is incorrect and should read "See sheet E2.01 for details".*

END OF ADDENDUM

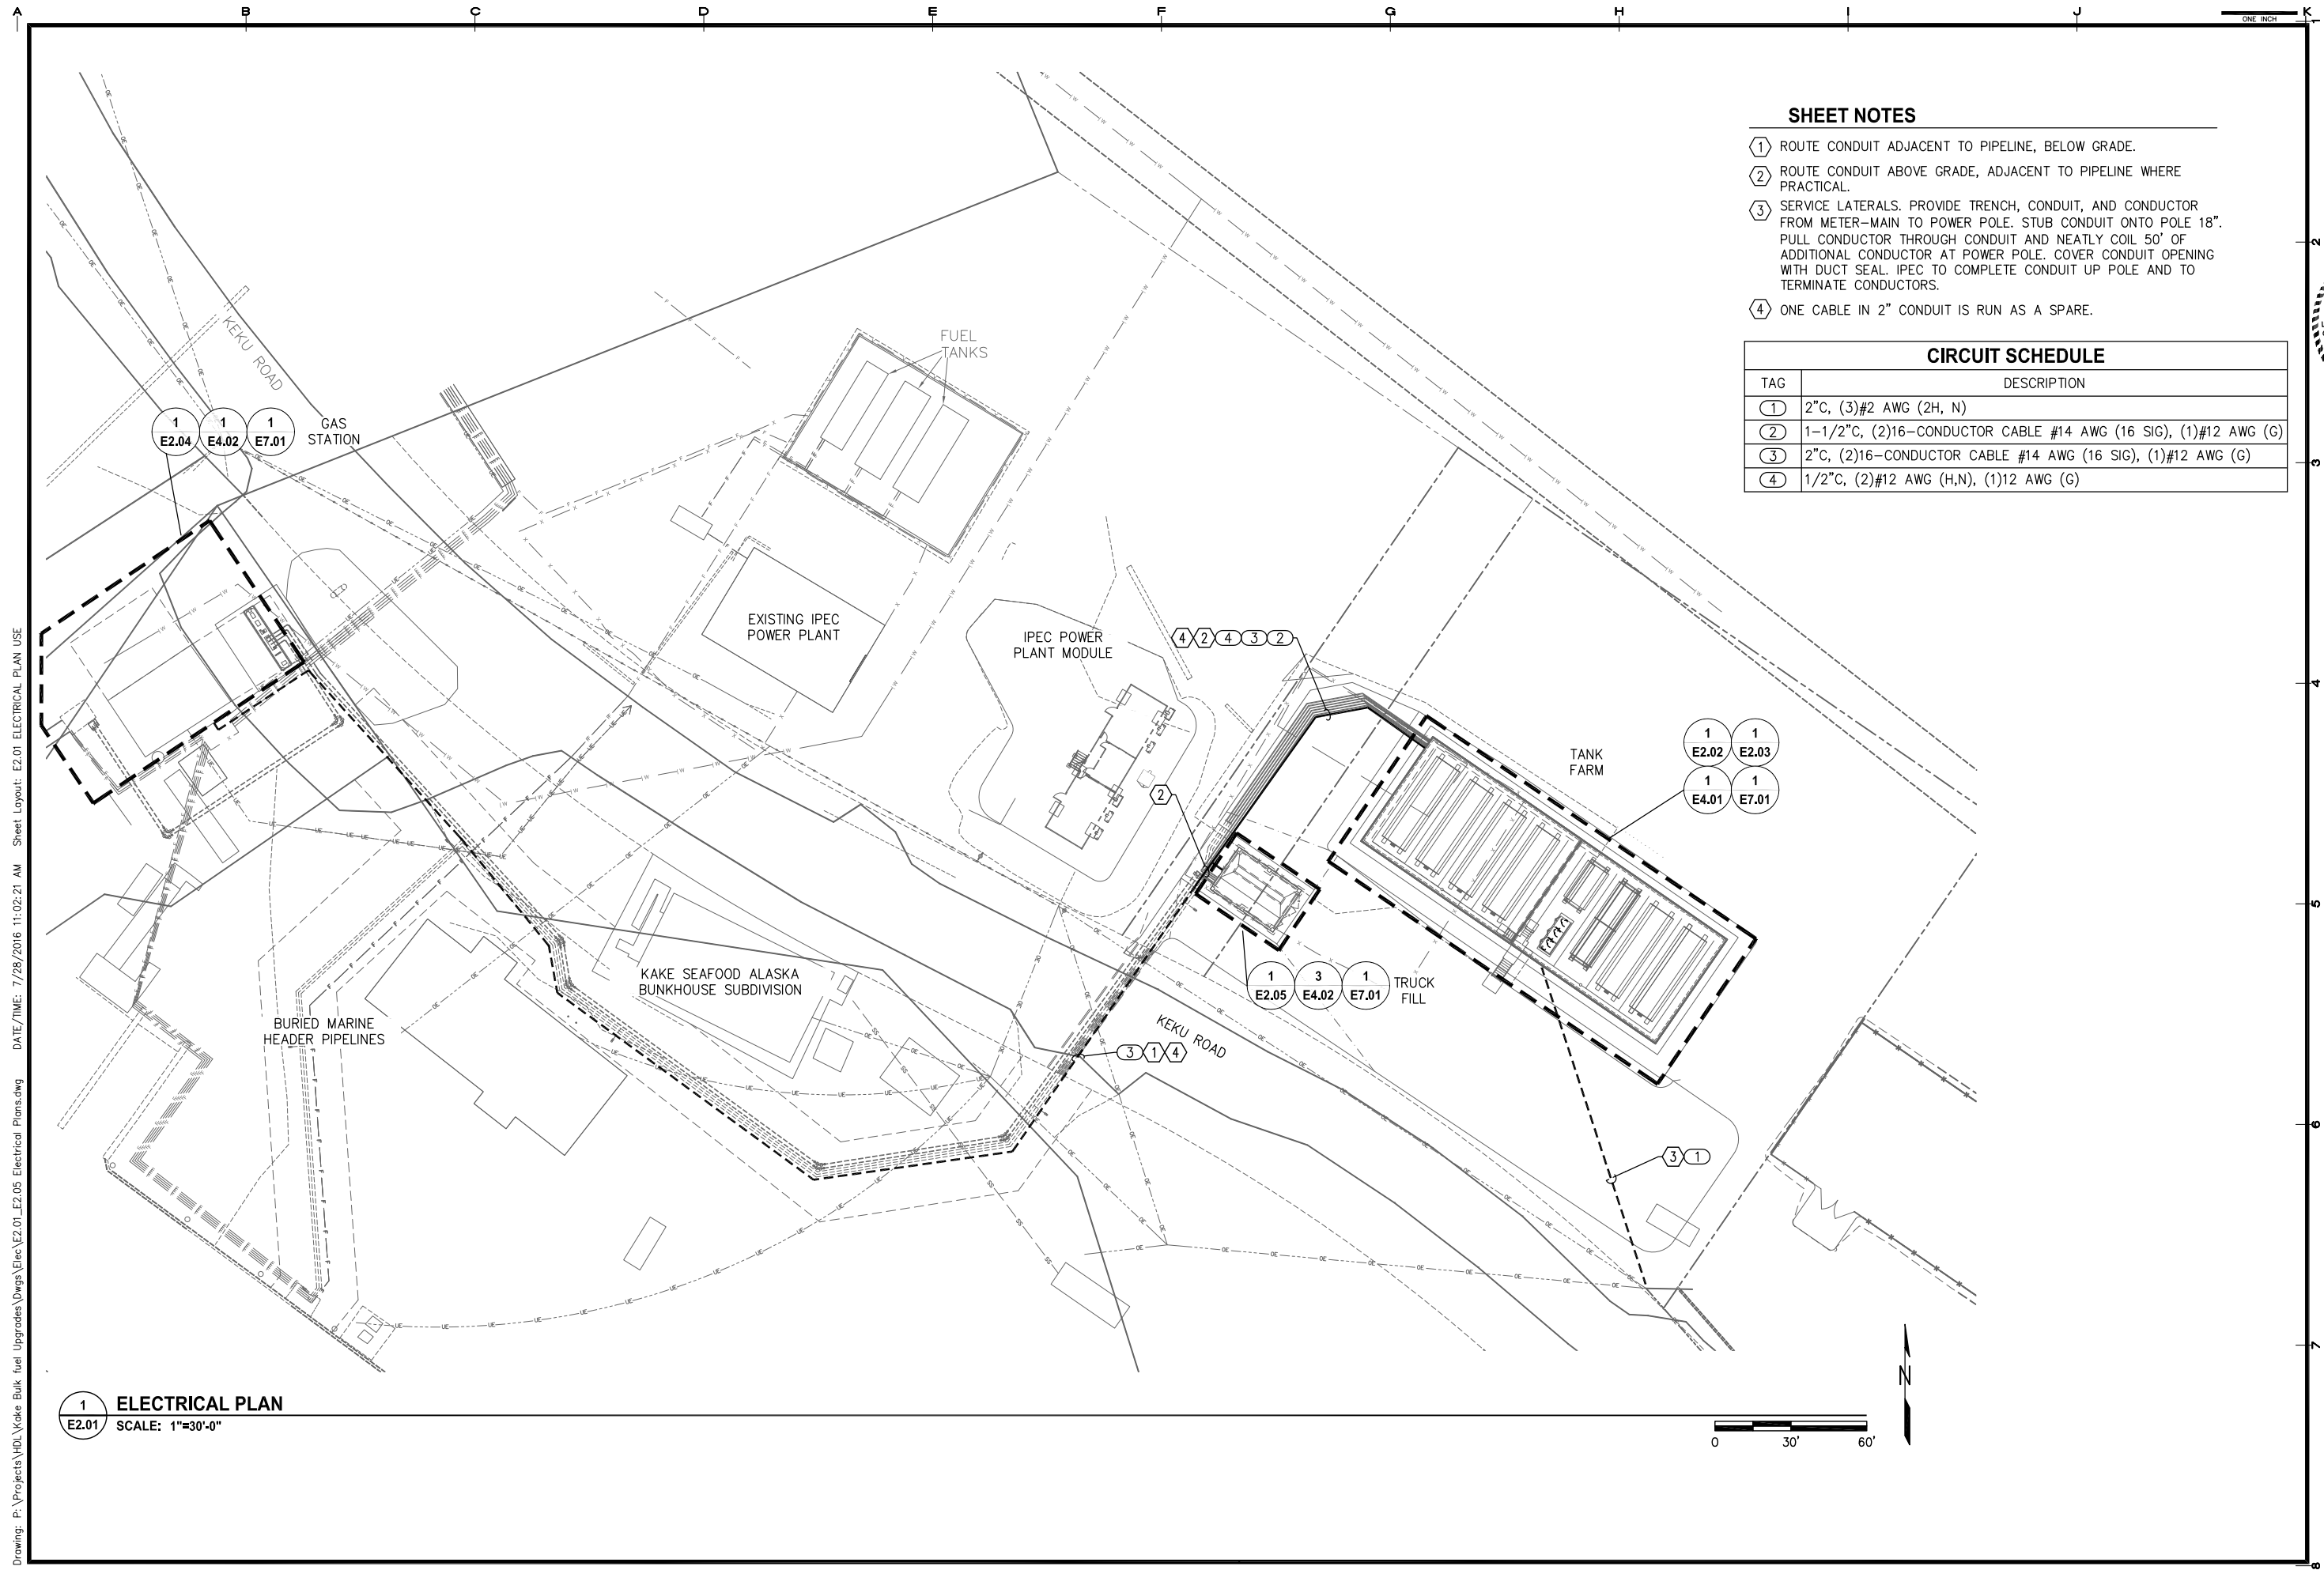


SHEET NOTES

- ① ROUTE CONDUIT ADJACENT TO PIPELINE, BELOW GRADE.
- ② ROUTE CONDUIT ABOVE GRADE, ADJACENT TO PIPELINE WHERE PRACTICAL.
- ③ SERVICE LATERALS. PROVIDE TRENCH, CONDUIT, AND CONDUCTOR FROM METER-MAIN TO POWER POLE. STUB CONDUIT ONTO POLE 18". PULL CONDUCTOR THROUGH CONDUIT AND NEATLY COIL 50' OF ADDITIONAL CONDUCTOR AT POWER POLE. COVER CONDUIT OPENING WITH DUCT SEAL. IPEC TO COMPLETE CONDUIT UP POLE AND TO TERMINATE CONDUCTORS.
- ④ ONE CABLE IN 2" CONDUIT IS RUN AS A SPARE.

CIRCUIT SCHEDULE

TAG	DESCRIPTION
①	2" C, (3)#2 AWG (2H, N)
②	1-1/2" C, (2)16-CONDUCTOR CABLE #14 AWG (16 SIG), (1)#12 AWG (G)
③	2" C, (2)16-CONDUCTOR CABLE #14 AWG (16 SIG), (1)#12 AWG (G)
④	1/2" C, (2)#12 AWG (H,N), (1)12 AWG (G)

REVISIONS	DATE	DESCRIPTION
1	7/13/2016	REVISE GAS STATION
2	7/29/2016	REVISE PLAN SCALE
3		
4		
5		

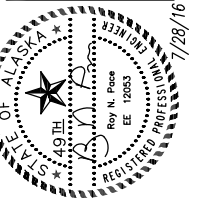

EDC, INC.
213 W. BREWSTER LANE
ANCHORAGE, AK 99503
(907) 276-7833



KAKE BULK FUEL UPGRADES
ALASKA ENERGY AUTHORITY
KAKE, ALASKA


1
E2.01
ELECTRICAL PLAN
SCALE: 1"=30'-0"

SHEET TITLE ELECTRICAL PLAN	
SHEET E2.01	
DRAWN BY: VI/OM	CHECKED BY: RP
DATE: 5/27/16	SCALE: AS NOTED
JOB NUMBER: 13-040	


Drawing: P:\Projects\HDI\Kake Bulk Fuel Upgrades\Drawings\Elec\E2.01_E2.05 Electrical Plans.dwg DATE/TIME: 7/28/2016 11:02:21 AM Sheet Layout: E2.01 ELECTRICAL PLAN USE

SHEET NOTES
 ① INTRINSICALLY SAFE CIRCUIT. INSTALL AND LABEL IN ACCORDANCE WITH ARTICLE 504 OF THE NEC.

REVISIONS	MARK	DATE	DESCRIPTION
1		7/14/2016	REVISE CONTROL PANEL ID
2		7/29/2016	REVISE CIRCUIT SCHED #1
3			
4			
5			

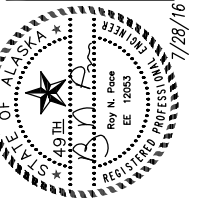

CIRCUIT SCHEDULE	
TAG	DESCRIPTION
①	SEE SHEET E2.01, TAG 3 FOR DETAILS.
②	SEE SHEET E2.02 FOR DETAILS.
③	1/2" C, (5)#12 AWG (3 SIG, H, N), (1)#12 AWG (G)
④	SEE SHEET E2.02 FOR DETAILS.
⑤	SEE SHEET E2.04 FOR DETAILS.
⑥	1/2" C, 1PR#12 AWG (2 SIG), (1)#12 AWG (G)

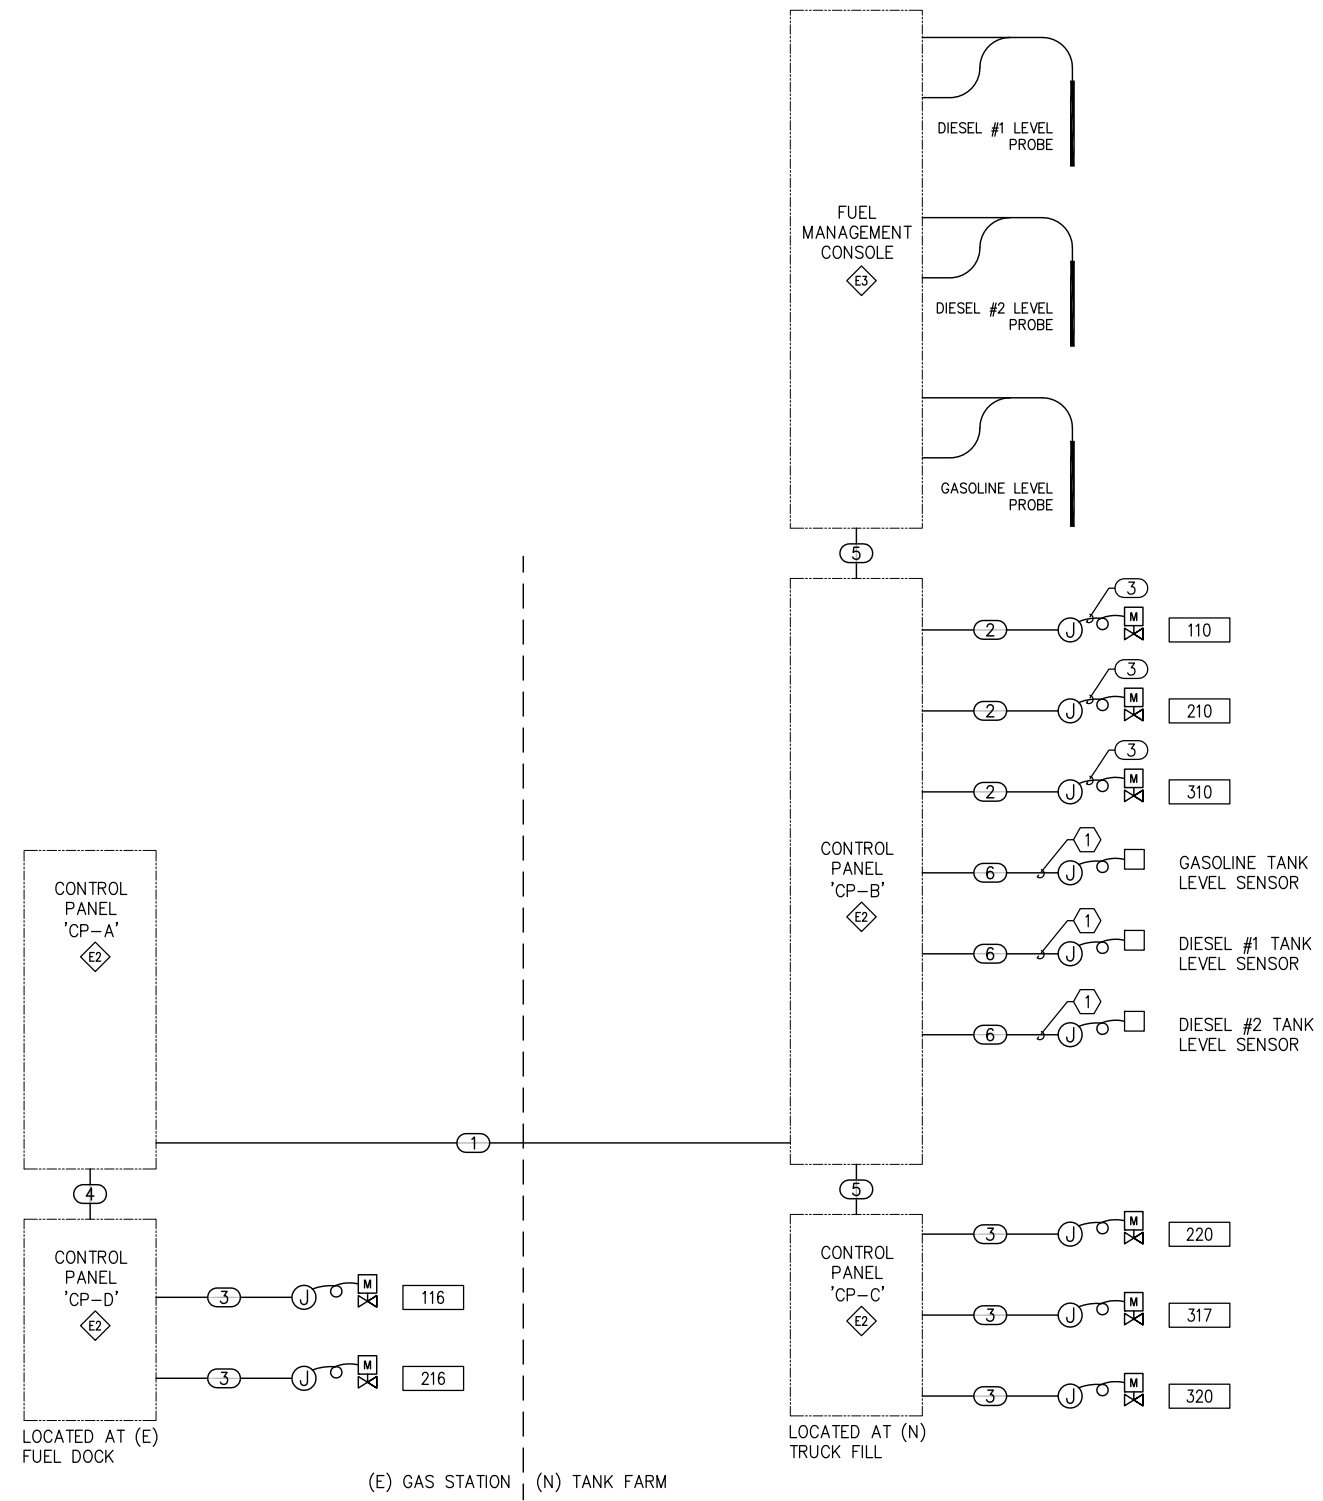

EDC, INC.
 213 W. FIREWEED LANE
 ANCHORAGE, AK 99503
 (907) 276-7933



KAKE BULK FUEL UPGRADES
ALASKA ENERGY AUTHORITY
 KAKE, ALASKA

SHEET TITLE
 CONTROL DIAGRAM

SHEET
 E5.01

DRAWN BY: VI/OM
 CHECKED BY: RP
 DATE: 5/27/16
 SCALE: AS NOTED
 JOB NUMBER: 13-040

1 CONTROL DIAGRAM
 E5.01 SCALE: NTS